


1 Site Plan
1 : 200

P1=UBC CAMPUS STANDARD PEDESTRIAN AREA LUMINAIRE.
TYPE SELUX SATURN 2 CUTOFF

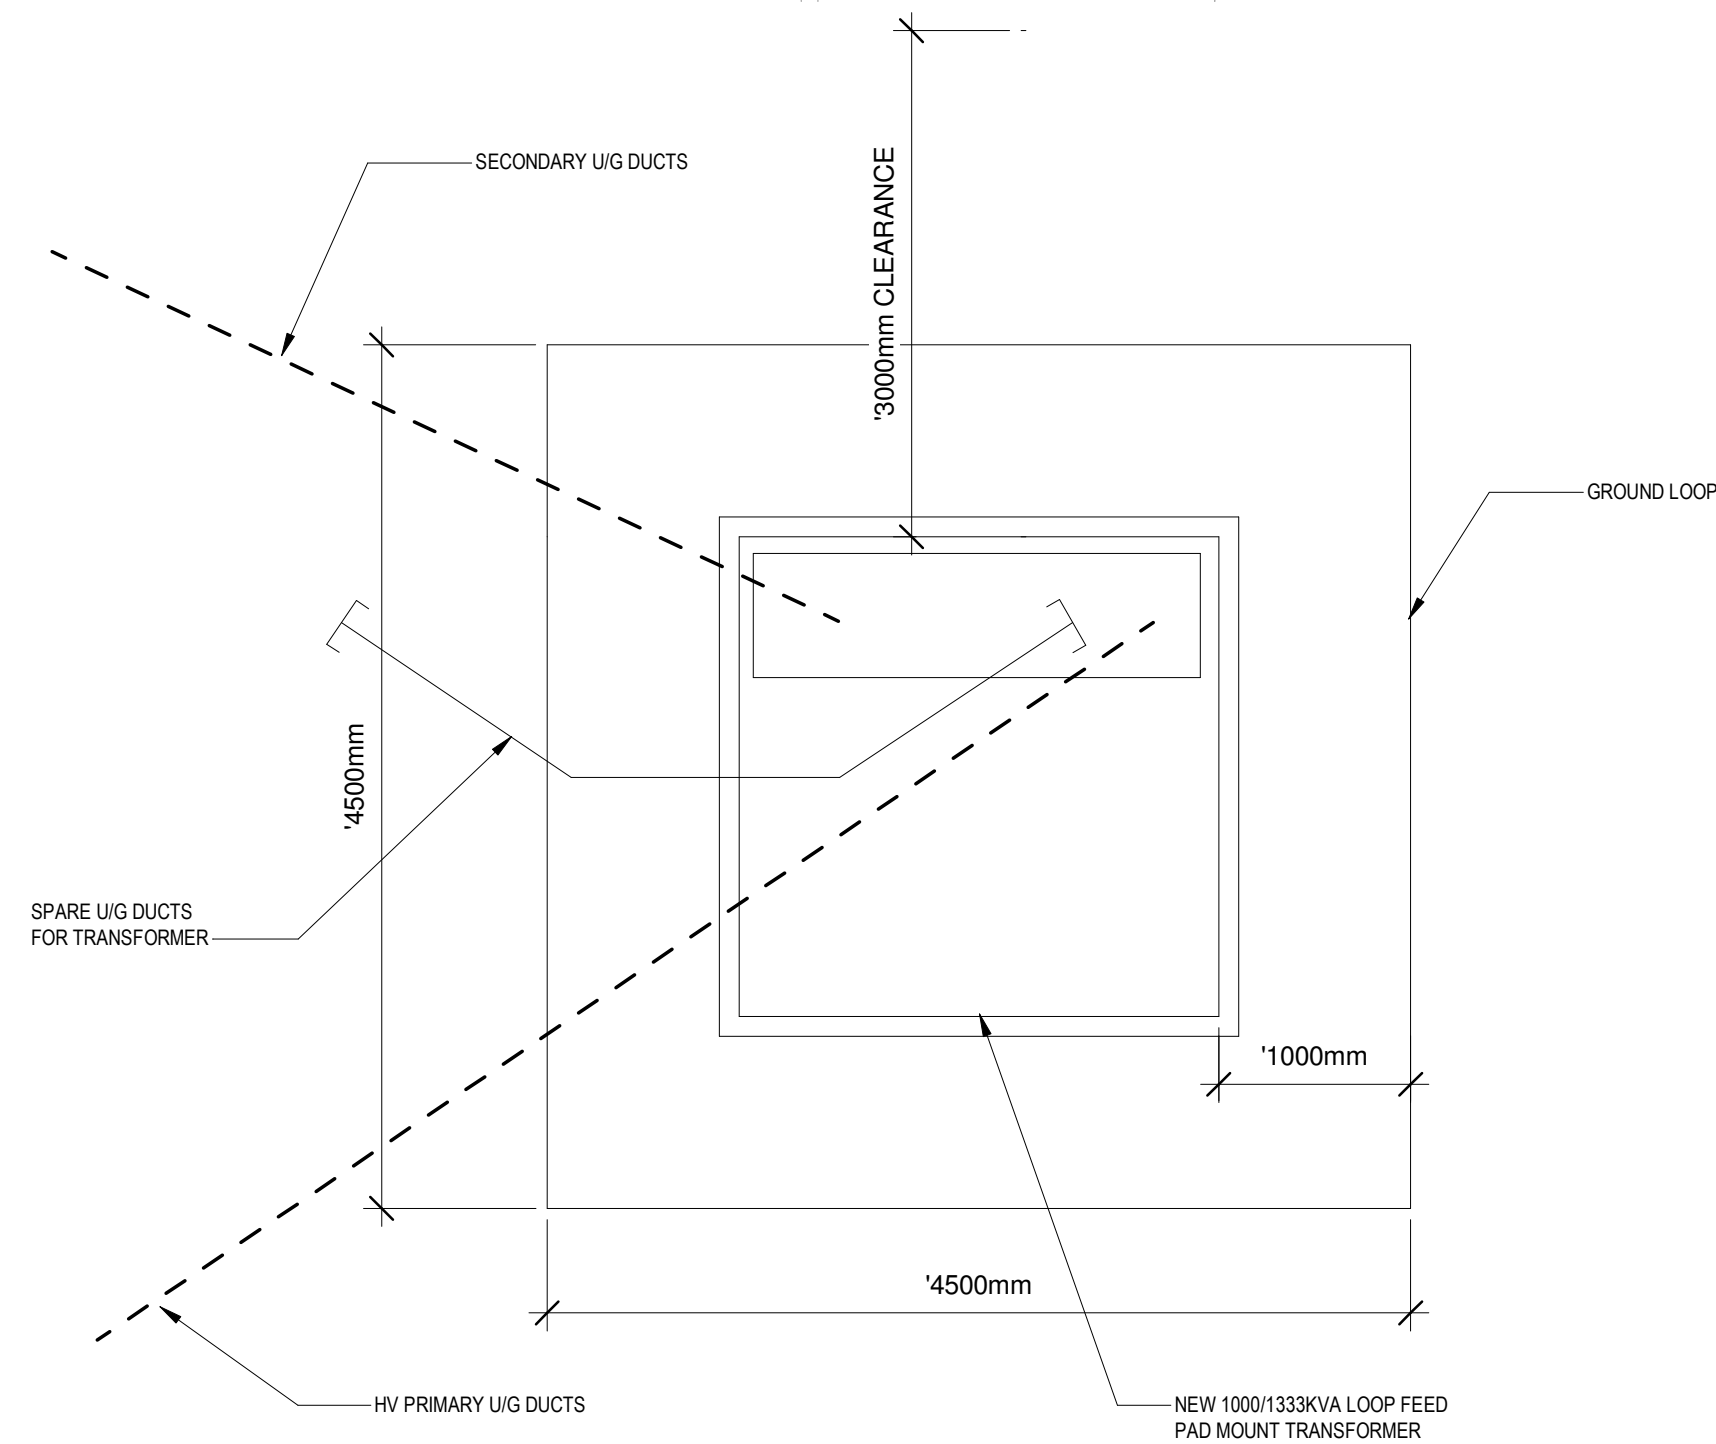


2 LOOP FEED PAD MOUNTED
TRANSFORMER DETAIL
NTS

DISCLAIMER: THIS DRAWING AND DESIGN IS COPYRIGHT PROTECTED WHICH SHALL NOT BE USED, REPRODUCED OR REVISED WITHOUT WRITTEN PERMISSION BY ARCHITECTURE 49. THE CONTRACTOR SHALL CHECK AND VERIFY ALL DIMENSIONS AND UTILITY LOCATIONS AND REPORT ALL ERRORS AND OMISSIONS PRIOR TO COMMENCING WORK. THIS DRAWING IS NOT TO BE SCALED.



ARCHITECTURE | 49

SEAL:

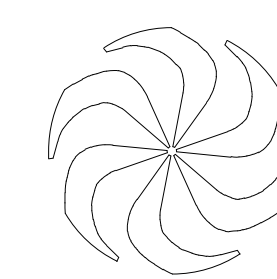

REV	DATE	REVISION DESCRIPTION	BY
C	2018-12-03	Issued for Development Permit	
B	2018-11-23	100% Design Development	
A	2018-10-17	100% Design Development For Review	

TRIUMF Canada's National Laboratory for Particle and Nuclear Physics 4004 Westbrook Mall | Vancouver BC | Canada V6T-2A3

INSTITUTE FOR ADVANCED MEDICAL ISOTOPES (IAMI)
Site Plan

DESIGNED	Designer	PLOT SCALE	As indicated	JOB NO.	DWG NO.	REV.
DRAWN	Author	DATE	Issue Date	Project Number	29252	
CHECKED	Checker					
WR #						
APPROVED						